
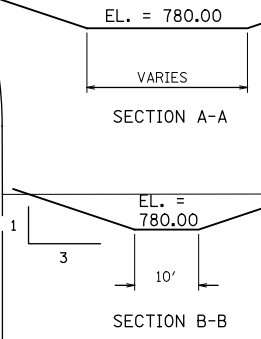


Washington Street

Sanitary Lift Station

East Big Horn Drive

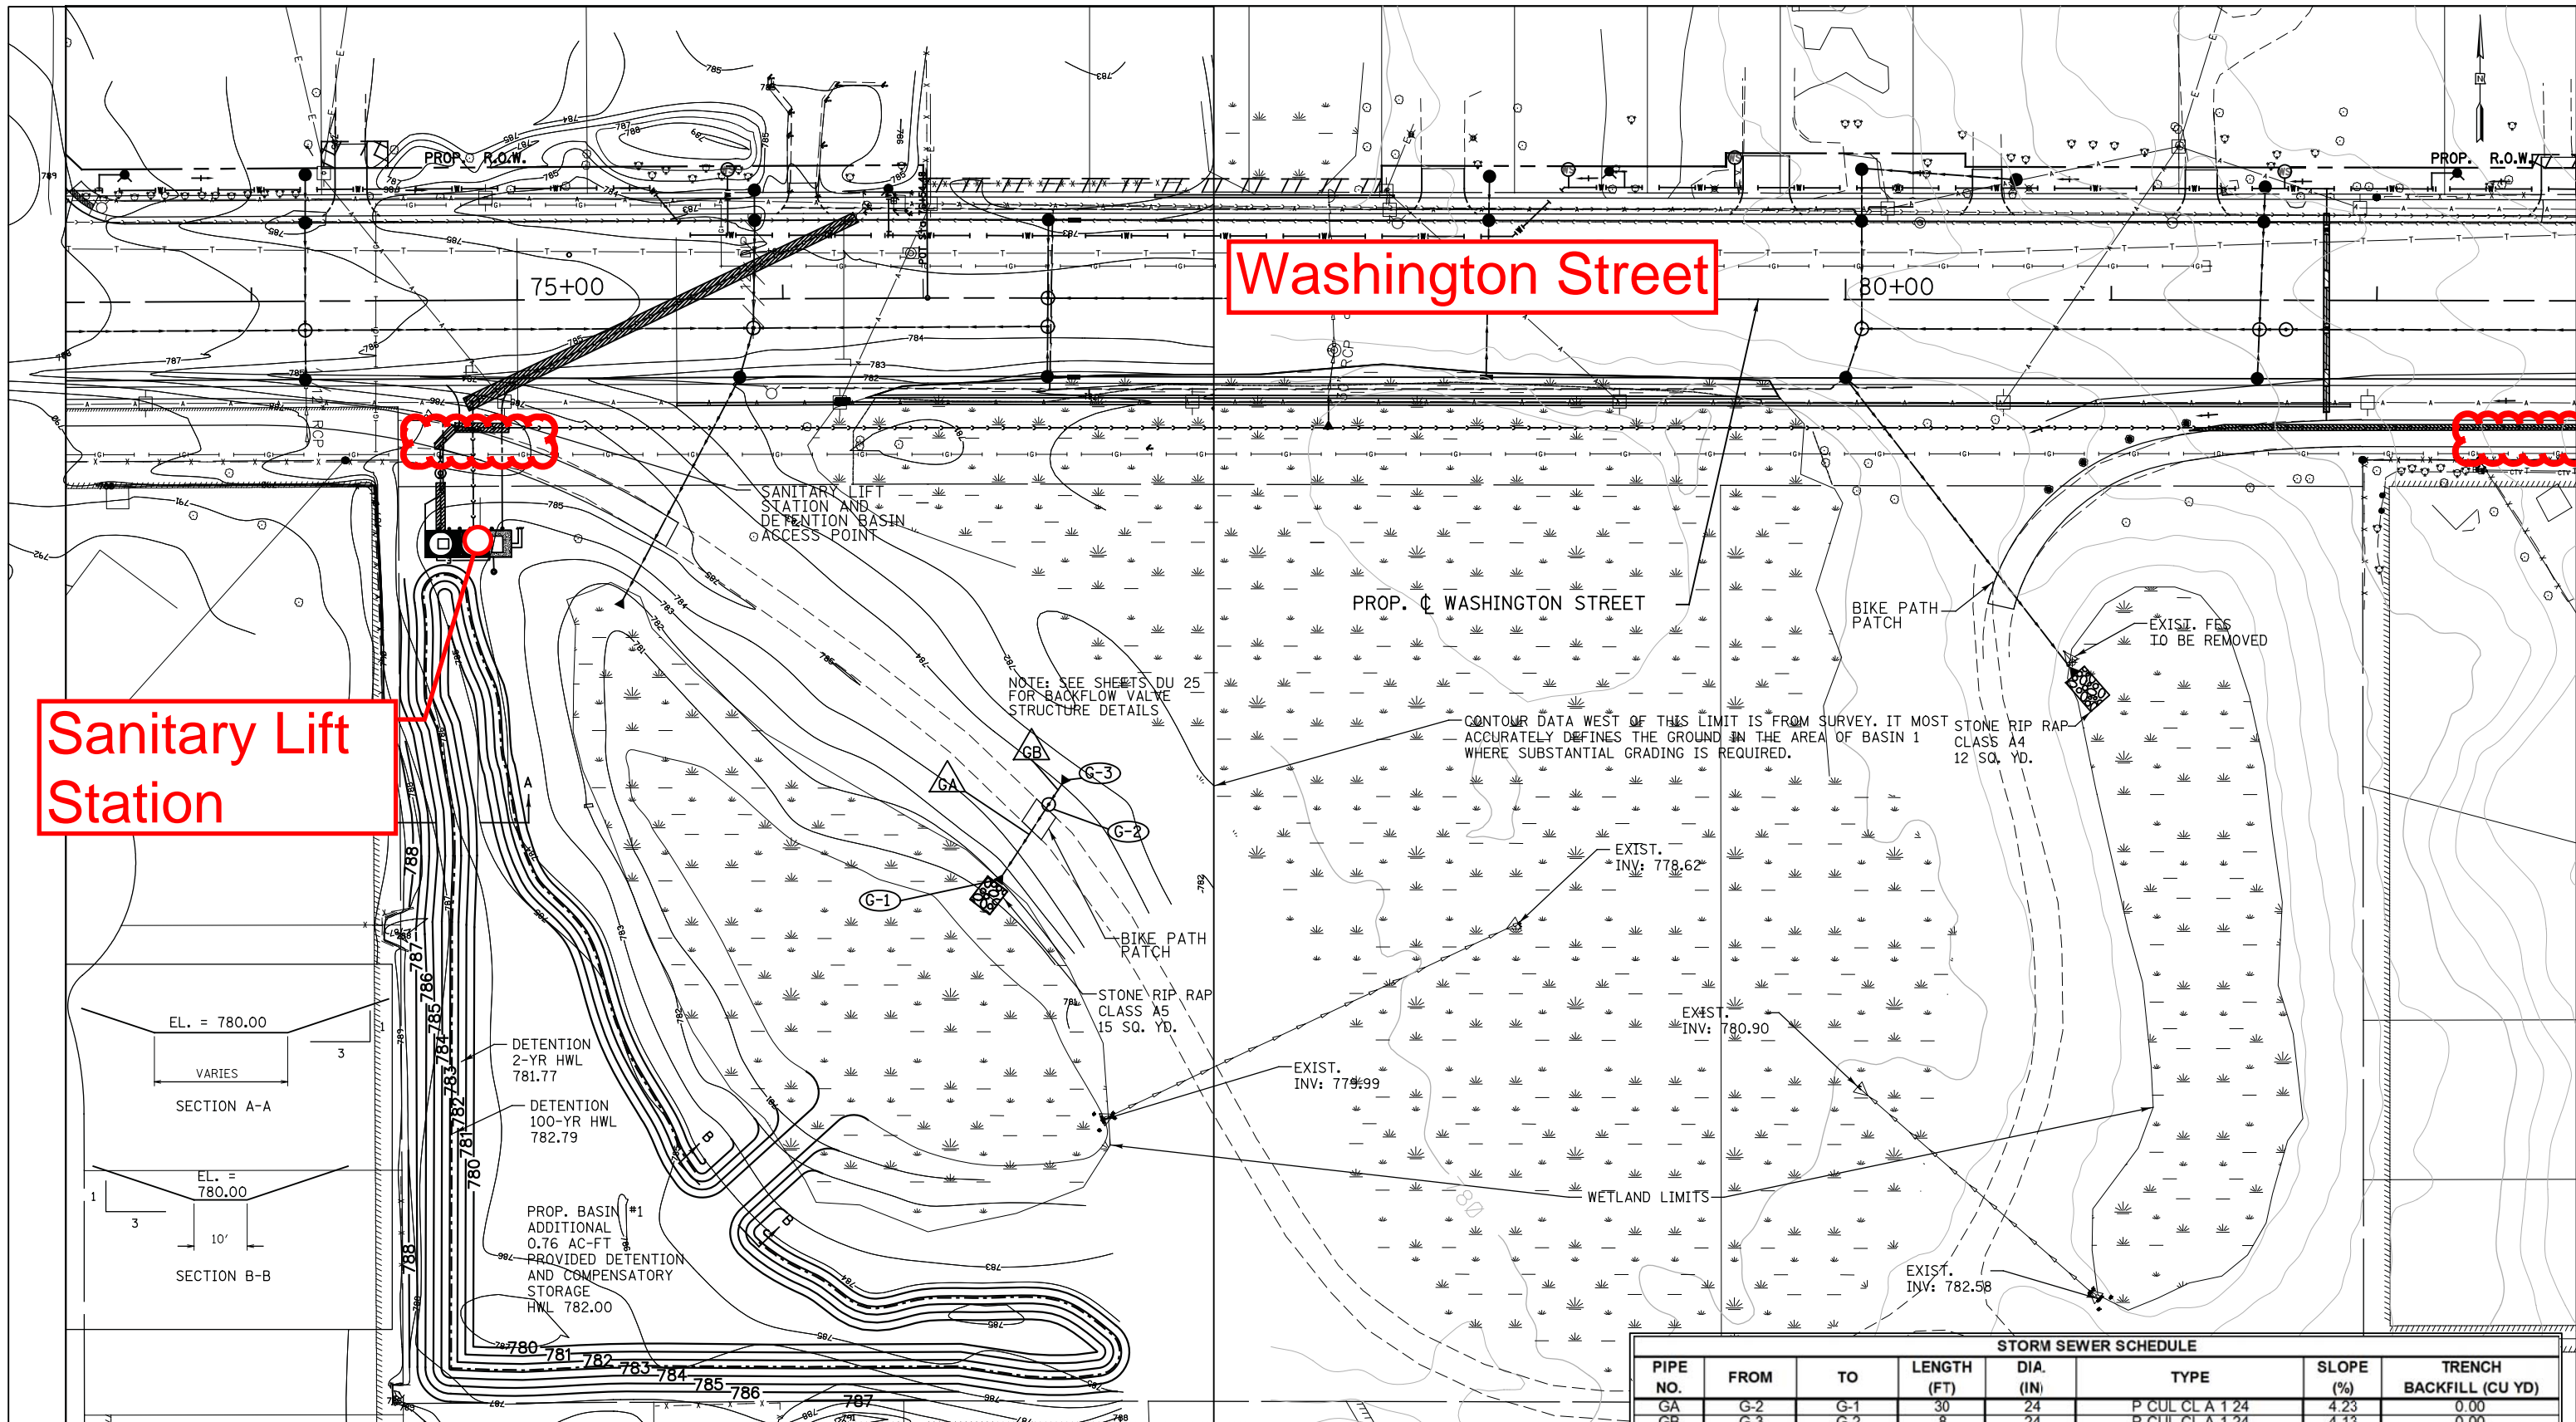

STORM SEWER SCHEDULE						
PIPE NO.	FROM	TO	LENGTH (FT)	DIA. (IN)	TYPE	TRENCH BACKFILL (CU YD)
GA	G-2	G-1	30	24	P CUL CL A 1 24	0.00
GB	G-3	G-2	8	24	P CUL CL A 1 24	0.00

DRAINAGE STRUCTURE SCHEDULE								
STRUCTURE NO.	STRUCTURE TYPE	STATION	OFFSET	RIM ELEV.	INVERT (N)	INVERT (S)	INVERT (W)	INVERT (E)
G-1	GRATED COVERT END SEC 24	75+80.54	218.78 RT	782.40			780.40	
G-2	MAN HOLE 4 DIA 11 CL	75+99.06	190.52 RT	783.50			781.67	781.67
G-2	SUR ON FLAT BOTTOM CHECK VALVE 24"	75+99.06	190.52 RT	783.50			781.67	781.67
G-3	GRATED COVERT END SEC 24	77+06.35	181.34 RT	784.00				782.00

LEGEND:

BOUNDARY LINES/SYMBOLS	EXISTING	PROPOSED
REFERENCE LINE/CENTERLINE OFFSET AND STATIONING	10+00	10+00
CONTOURS	881	881
2-YR DETENTION HIGH WATER LEVEL (HWL)	---	---
100-YR DETENTION HIGH WATER LEVEL (HWL)	---	---

HIGH WATER LEVEL AND EXISTING CONTOURS FROM RESURFACING PLANS BY ENVIRODYNE ENGINEERING, DATED AUG, 1990; AND PROPOSED BIKEPATH PLANS BY LCDOT DATED NOV 30, 2001



PATRICK ENGINEERING INC. 4970 VARSITY DRIVE LISLE, IL 60532 patrickengineering.com	USER NAME = zcoromski(Rdwj-Lisle) PLOT CONFIG = PDF(Grey_Small).plt PLOT DATE = 5/8/2015 2:59:10 PM	DESIGNED - ZSC DRAWN - ZSC CHECKED - EYC DATE - 4/23/2015	REVISED - 05/11/2015 ADDENDUM REVISED - REVISED - REVISED -
---	---	--	--



WASHINGTON STREET FROM HAINESVILLE TO HARYAN WAY
BASIN 1 GRADING PLAN
SCALE: 1"=30'

F.A.U. RTE.	SECTION	COUNTY	TOTAL SHEETS	SHEET NO.
187	11-00121-10-WR	LAKE	439	118

G:\LCDOT\21150_005\Drawings\shhs\Drawings\Draw_17_Grading_01.dgn